

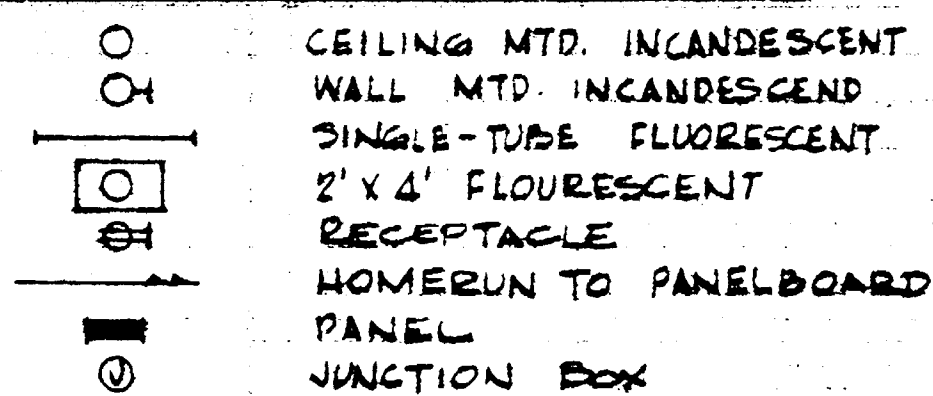


ELECTRIC SYMBOLS

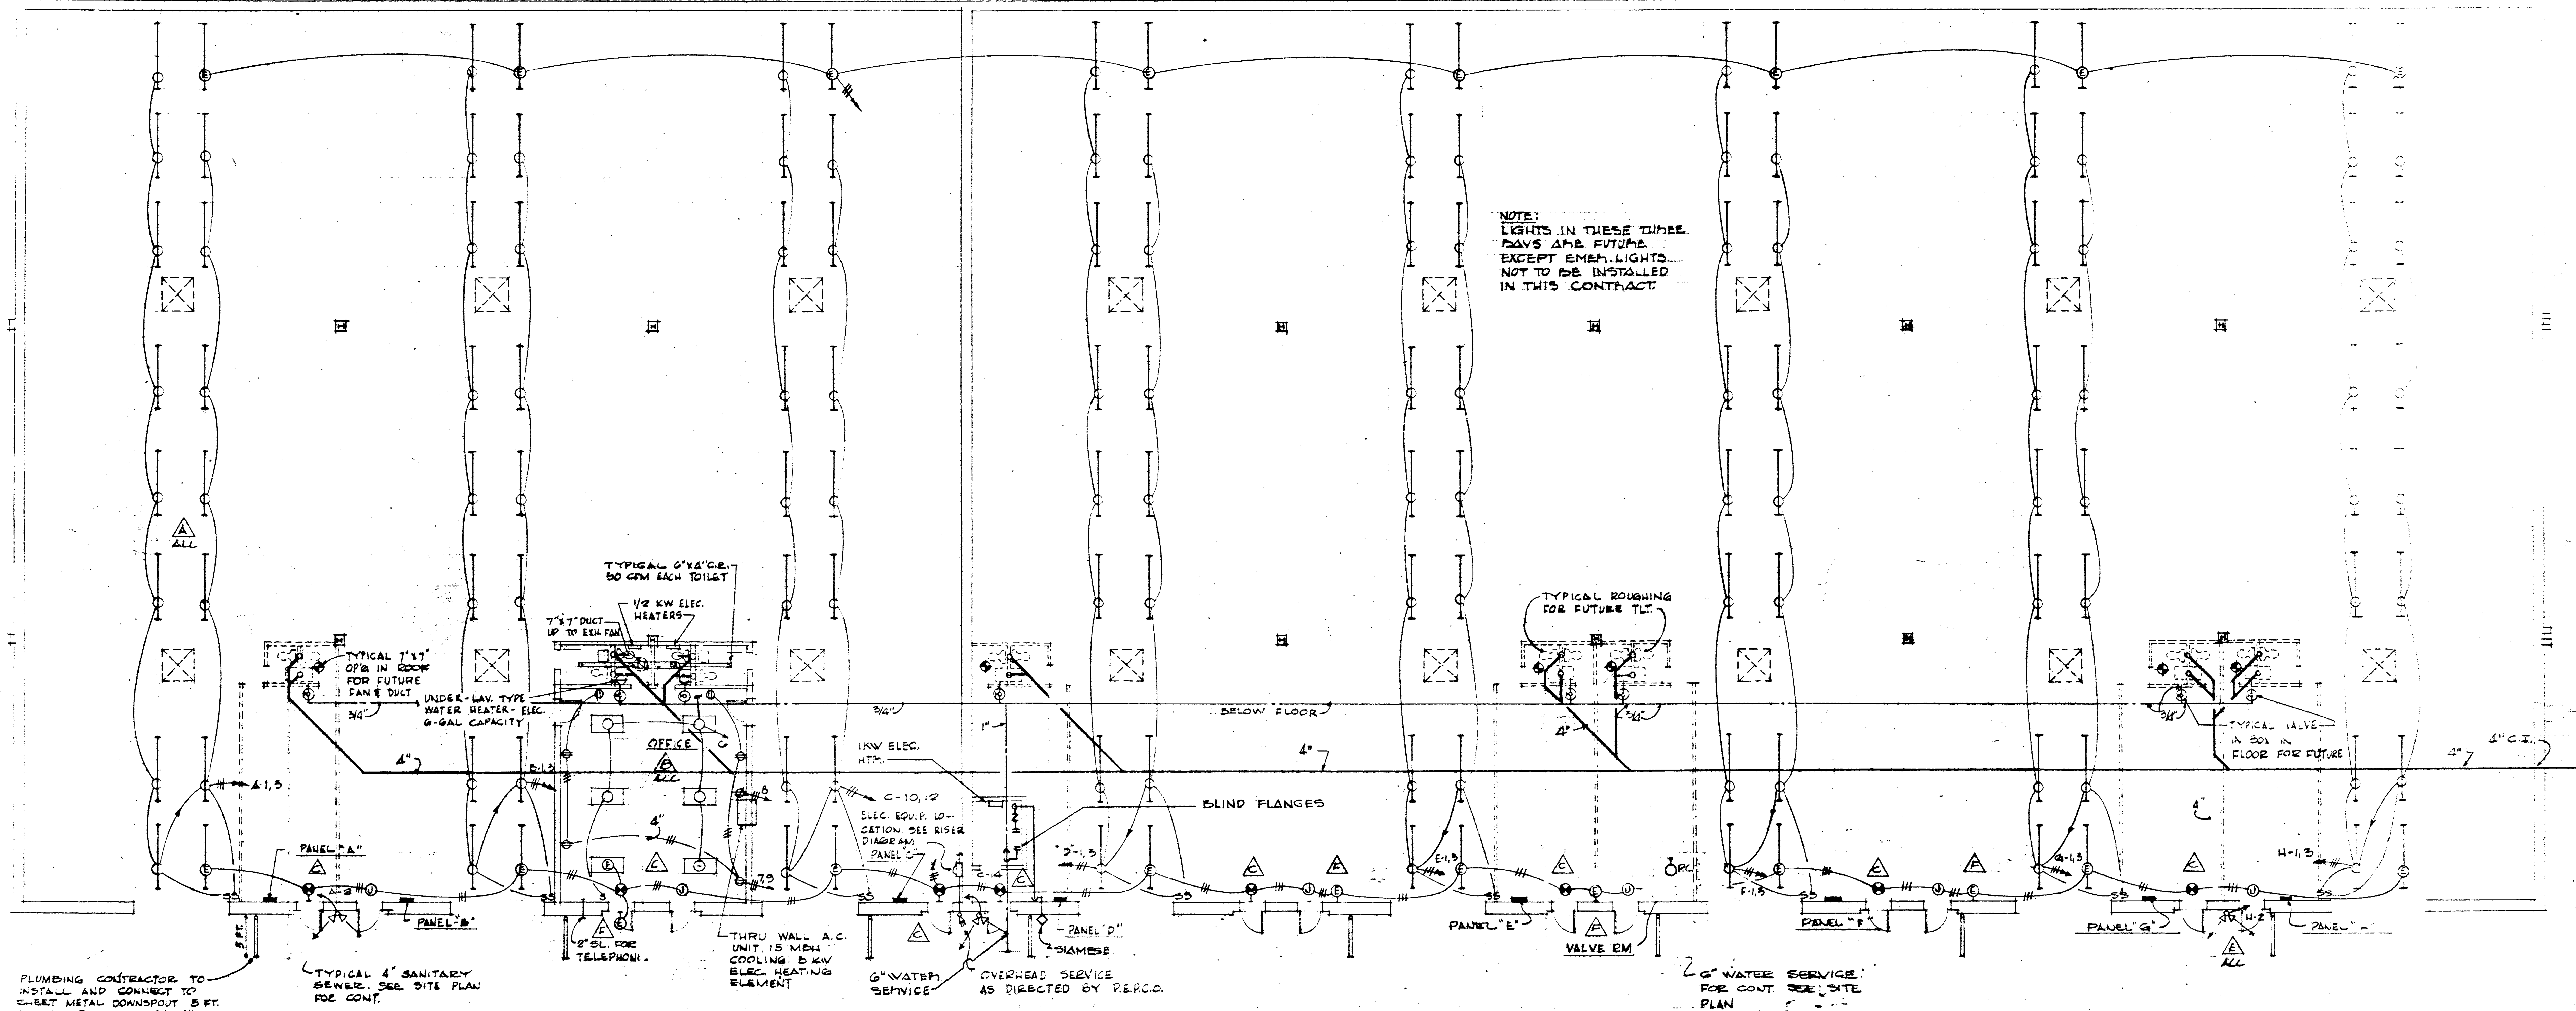


MECHANICAL SYMBOLS

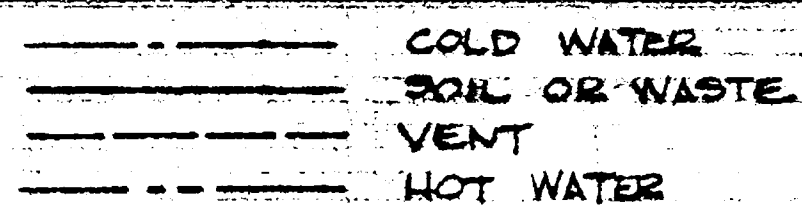


FLOOR PLAN
SCALE: 1/8"=1'-0"


NOTE: ENTIRE WAREHOUSE SHALL BE SPRINKLERED IN ACCORDANCE WITH N.F.P.A. PAMPHLET AND ALL APPLICABLE CODES OF PRINCE GEORGES COUNTY. SPRINKLERS SHALL BE DRY SYSTEM.

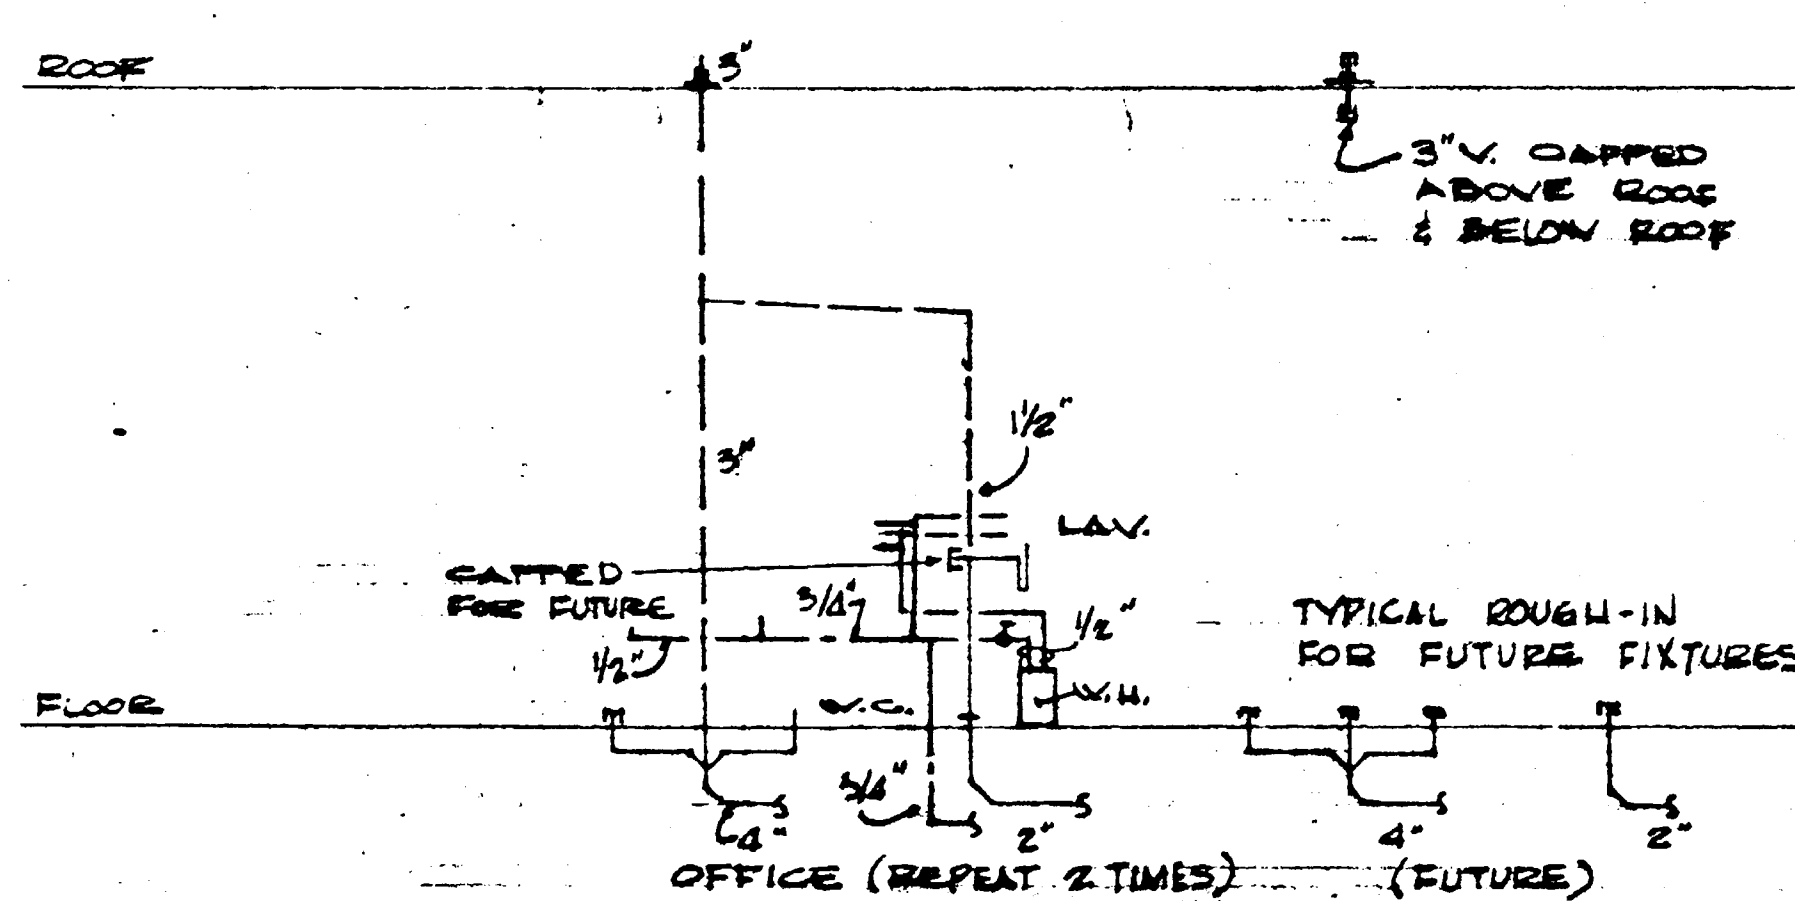


SANITARY DRAINAGE DIAGRAM
NO SCALE

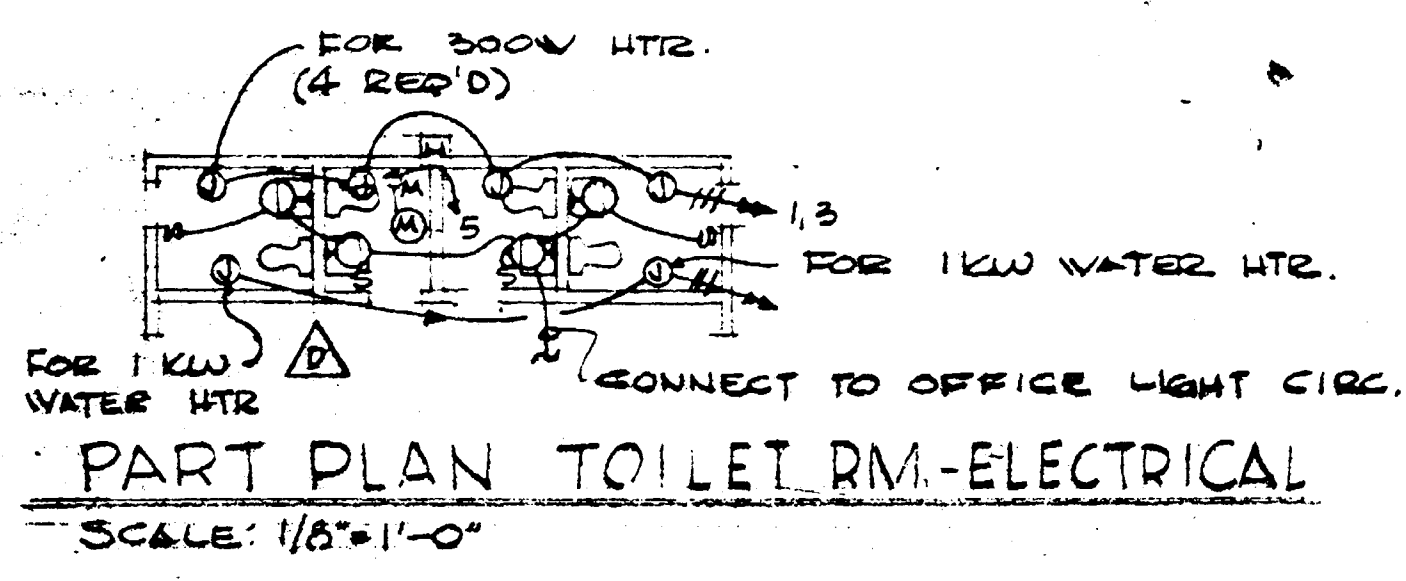

PART PLAN TOILET RM.-ELECTRICAL
SCALE: 1/8"=1'-0"

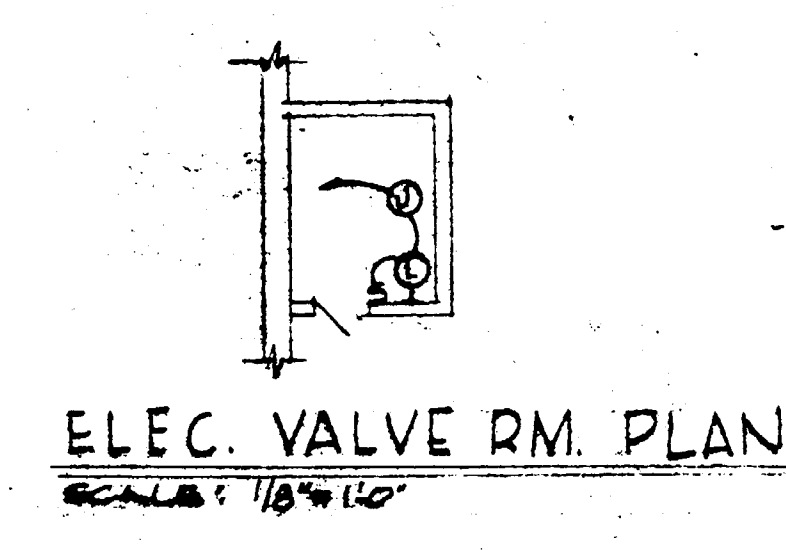

ELEC. VALVE RM. PLAN
SCALE: 1/8"=1'-0"

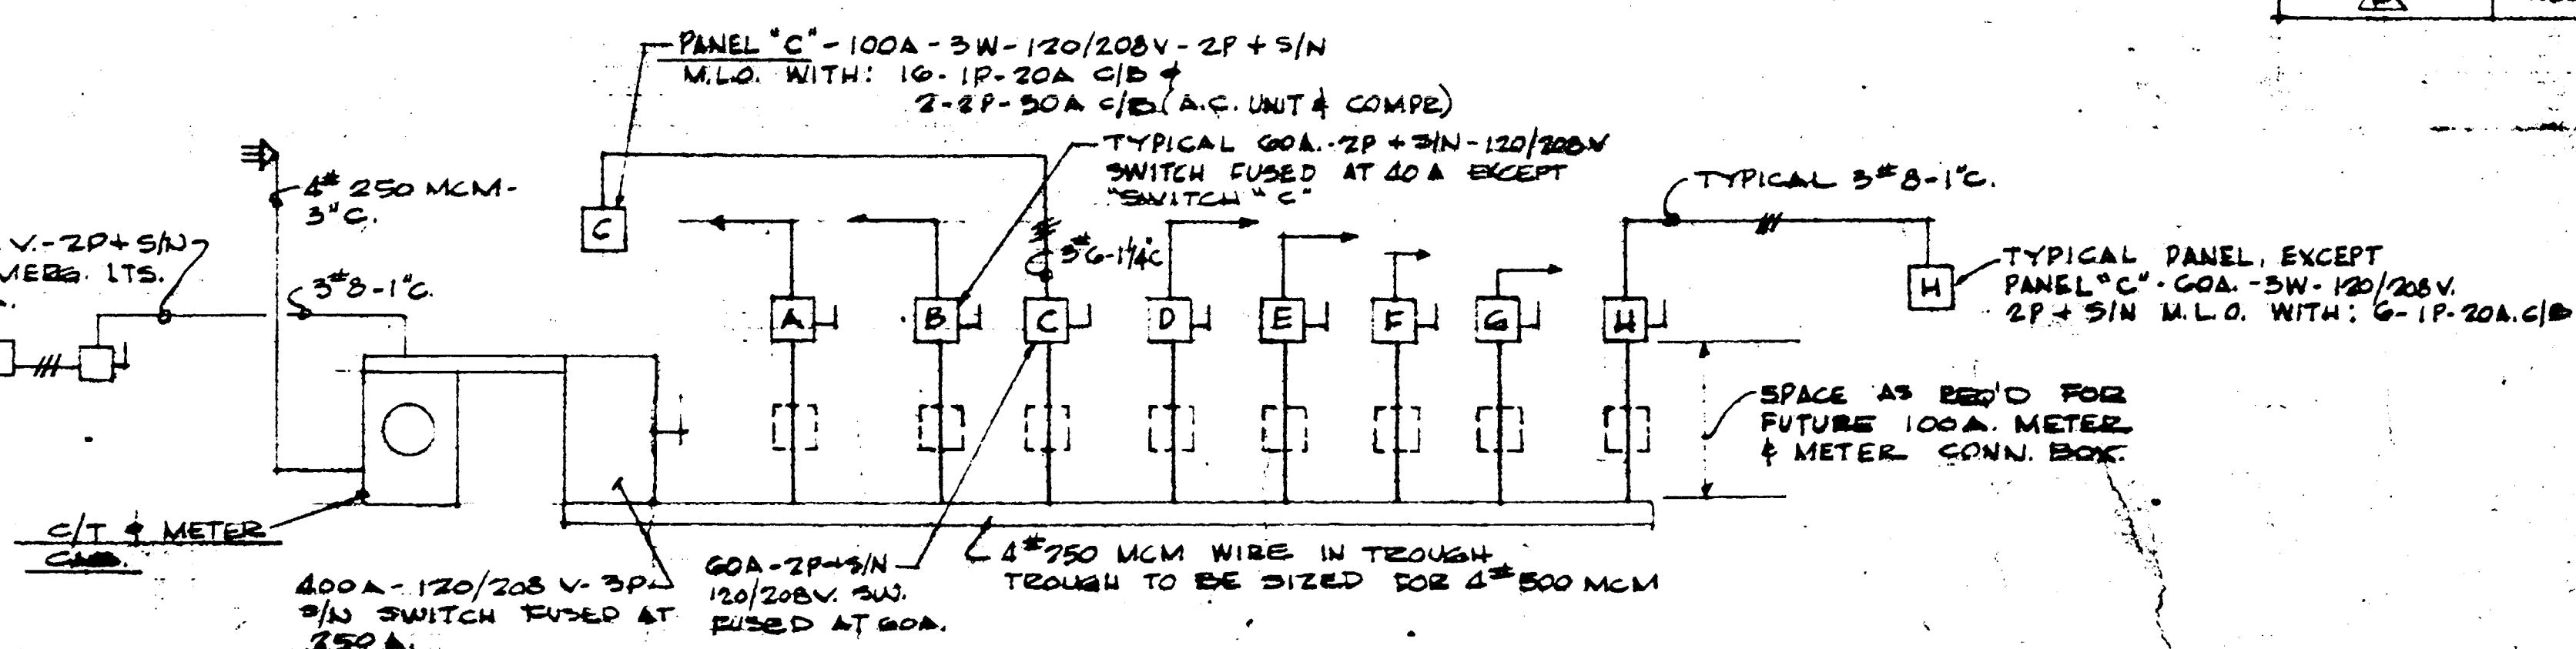

ELECTRICAL RISER DIAGRAM
NO SCALE

SYMBOL	MARK'S	LAMP	REMARKS
▲	LEGION #2450-296	2-100 W.-FL.	CEILING MTD. ABOVE BOTTOM OF CEILING
▲	LEGION #3515-440	4-40 W.-FL.	CEILING MTD.
▲	PERFECLITE # P-800	2-25 W.-I.F.	CEILING OR WALL MTD.
▲	SOLO # 9560-1	1-75 W.-I.F.	WALL MTD.
▲	SPAULDING # 952	2-250 W.-I.F.	WALL MTD.
▲	PRESCOLITE # WD-24	1-100 W.-I.F.	WALL MTD.



WAREHOUSE NO. 4

MARTIN INDUSTRIAL PARK VENTURE
3045 University Blvd E.
Adelphi, Maryland

MEDIA AND ASSOC.
Consulting Engineers
157 Silver Spring Ave.
Silver Spring Md.